


马图	结构	强电	采暖通入空气调节
建筑	给水排水	弱电	动力
ARCHITECTURE	PLUMBING	ELECTRICITY	POWER

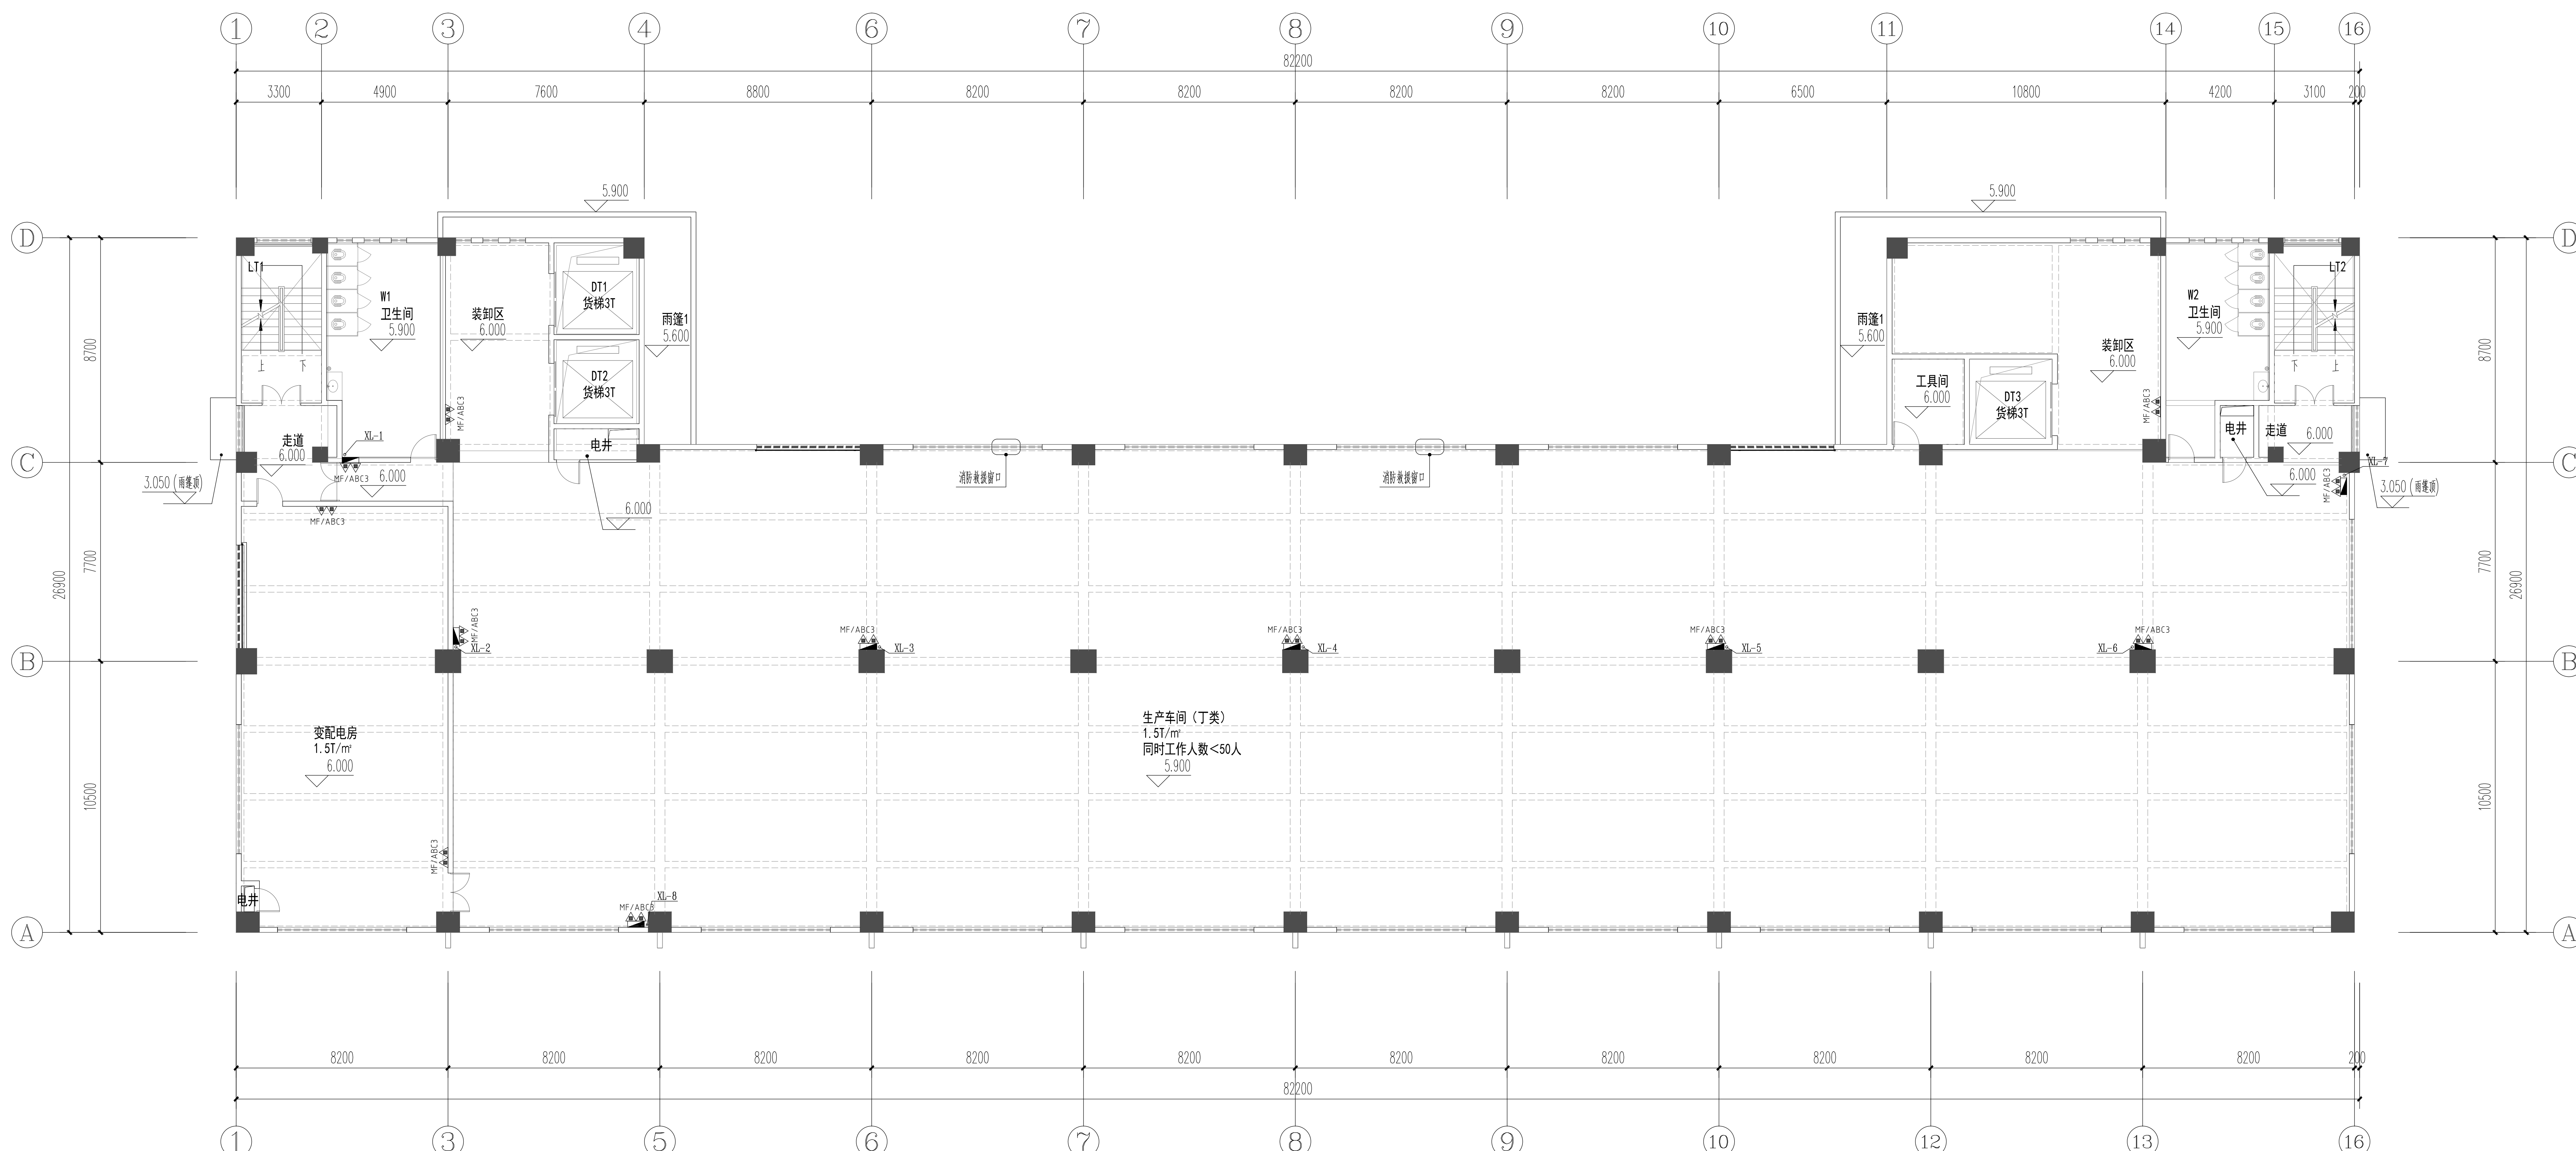

## 二层消防平面图 1:100



JUANXUE ARCHITECTURE & ENGINEERING DESIGN INS. CO., LTD

No.A111010257 Class A of Architecture Design P.R.C

CLIENT

东莞市荣欣实业投资有限公司

CO-OPERATED WITH

[illegible]

PROJECT NAME

॥

---

PROJECT NO.

ITEM NAME

AUTHORIZED F

项目负责人

专业负责人

校对人  
APPROVED BY

DESIGNED BY

DRAWN BY

DRAWING TITLE

STATUS CONST

ARCHIVES NO.	
図号	

馬休山園水田

个人执业专用:

本图须加盖本公司出图签章, 否则一律无效

COPYRIGHT(C)2014,JD AEDI CO., L

Copyright © 2014, Stuvia.com, Inc.