


总图 SITE		结构 STRUCTURE		强电 ELECTRICITY		采暖通风空气调节 HVAC
建筑 ARCHITECTURE		给水排水 PLUMBING		弱电 ELECTRICITY		动力 POWER

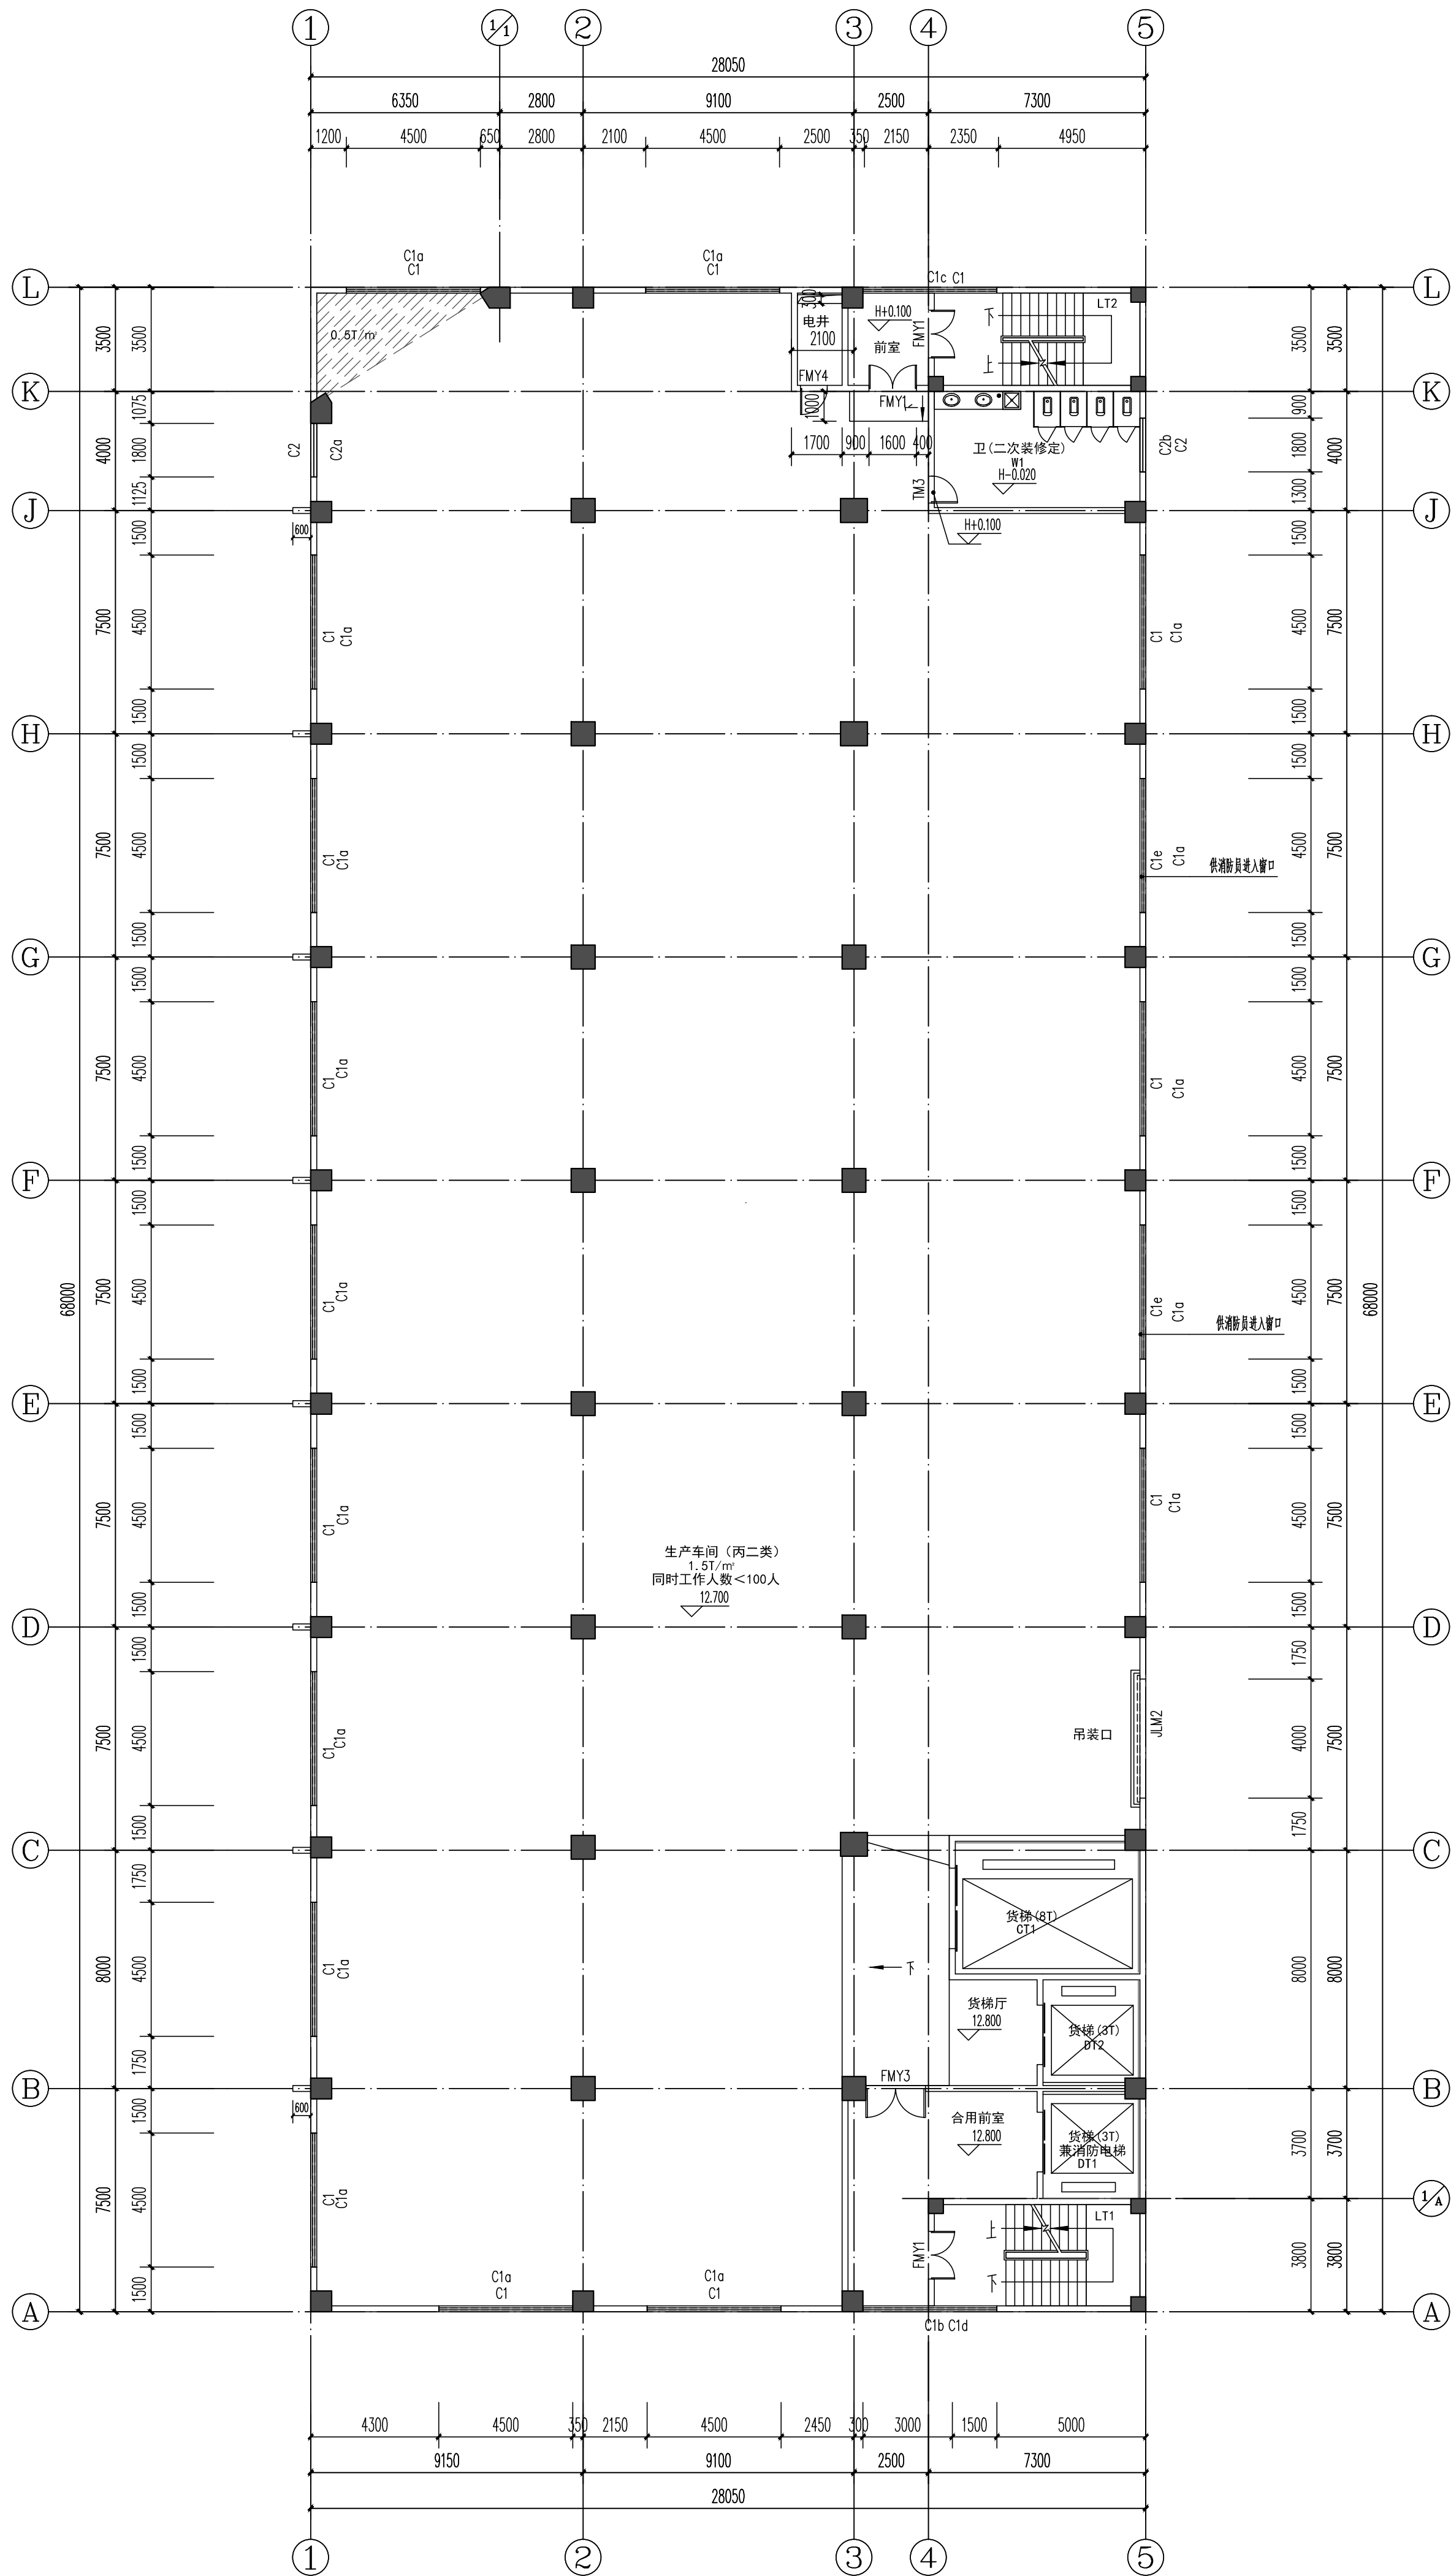


三平面图 1:150

建筑面积:1907.40m<sup>2</sup>

说明:

1. 图中未标注门窗洞口或100mm, 结构柱边门垛<200mm的为混凝土门垛。
2. 配电箱箱体口位置及半径详电气施工图, 电井留洞详平面图, 设备安装完成后回填防火材料。
3. 消防栓箱尺寸: 800×650×240, 离地高度960高, 安装方式详水电专业图纸。
4. 排水管在墙体及梁柱上的留洞位置详给排水施工图及结构施工图。
5. 窗台低于900的窗户内均设钢骨架栏杆, 栏杆高度由窗台面算起。
6. 除特别说明外, 门框做法为混凝土, 混凝土强度等级及窗台面与墙同标号。
7. 明确所有标注的反映高度均乘以(楼层标高/计算

建筑名称 ARCHITECTURE DESIGN			
建学建筑与工程设计有限公司 JIANXUE ARCHITECTURE & ENGINEERING DESIGN CO., LTD. 工部设计字(东)建字(东)001100057 No.11100257 Class A of Architectural Design P.E.C			
建设单位 CLIENT		东莞市荣洋实业投资有限公司	
合作设计单位 CO-OPERATED WITH			
CS-OPERATED WITH			
工程名称 PROJECT NAME		常平双保专业基地A-04地块 电子工业项目	
工程编号 PROJECT NO.		JXG-2022-04	
项目名称 ITEM NAME		1号厂房	
设计人 DESIGNER	审核人 CHECKER	姓名 NAME	姓名 NAME
ALPHABETIZED FOR ISSUE BY	ALPHABETIZED FOR ISSUE BY	廖志	廖志
PROJECT MANAGER	PROJECT MANAGER	廖志	廖志
CHIEF ENGINEER	CHIEF ENGINEER	廖志	廖志
APPROVED BY	APPROVED BY	廖志	廖志
DESIGNED BY	DESIGNED BY	廖志	廖志
DRAWN BY	DRAWN BY	廖志	廖志
DRAWING TITLE DRAWING TITLE			
三、四层平面图			
设计比例 SCALE	第三层平面图 THIRD FLOOR PLAN	第四层平面图 FOURTH FLOOR PLAN	比例 SCALE
ARCHITECTS NO.	JXG-01-03	比例 SCALE	1:150
ACADEMIC SPECIAL SEAL			
PERSONAL SEAL			
PROJECT PERSON SEAL			
PERSONAL SEAL			